


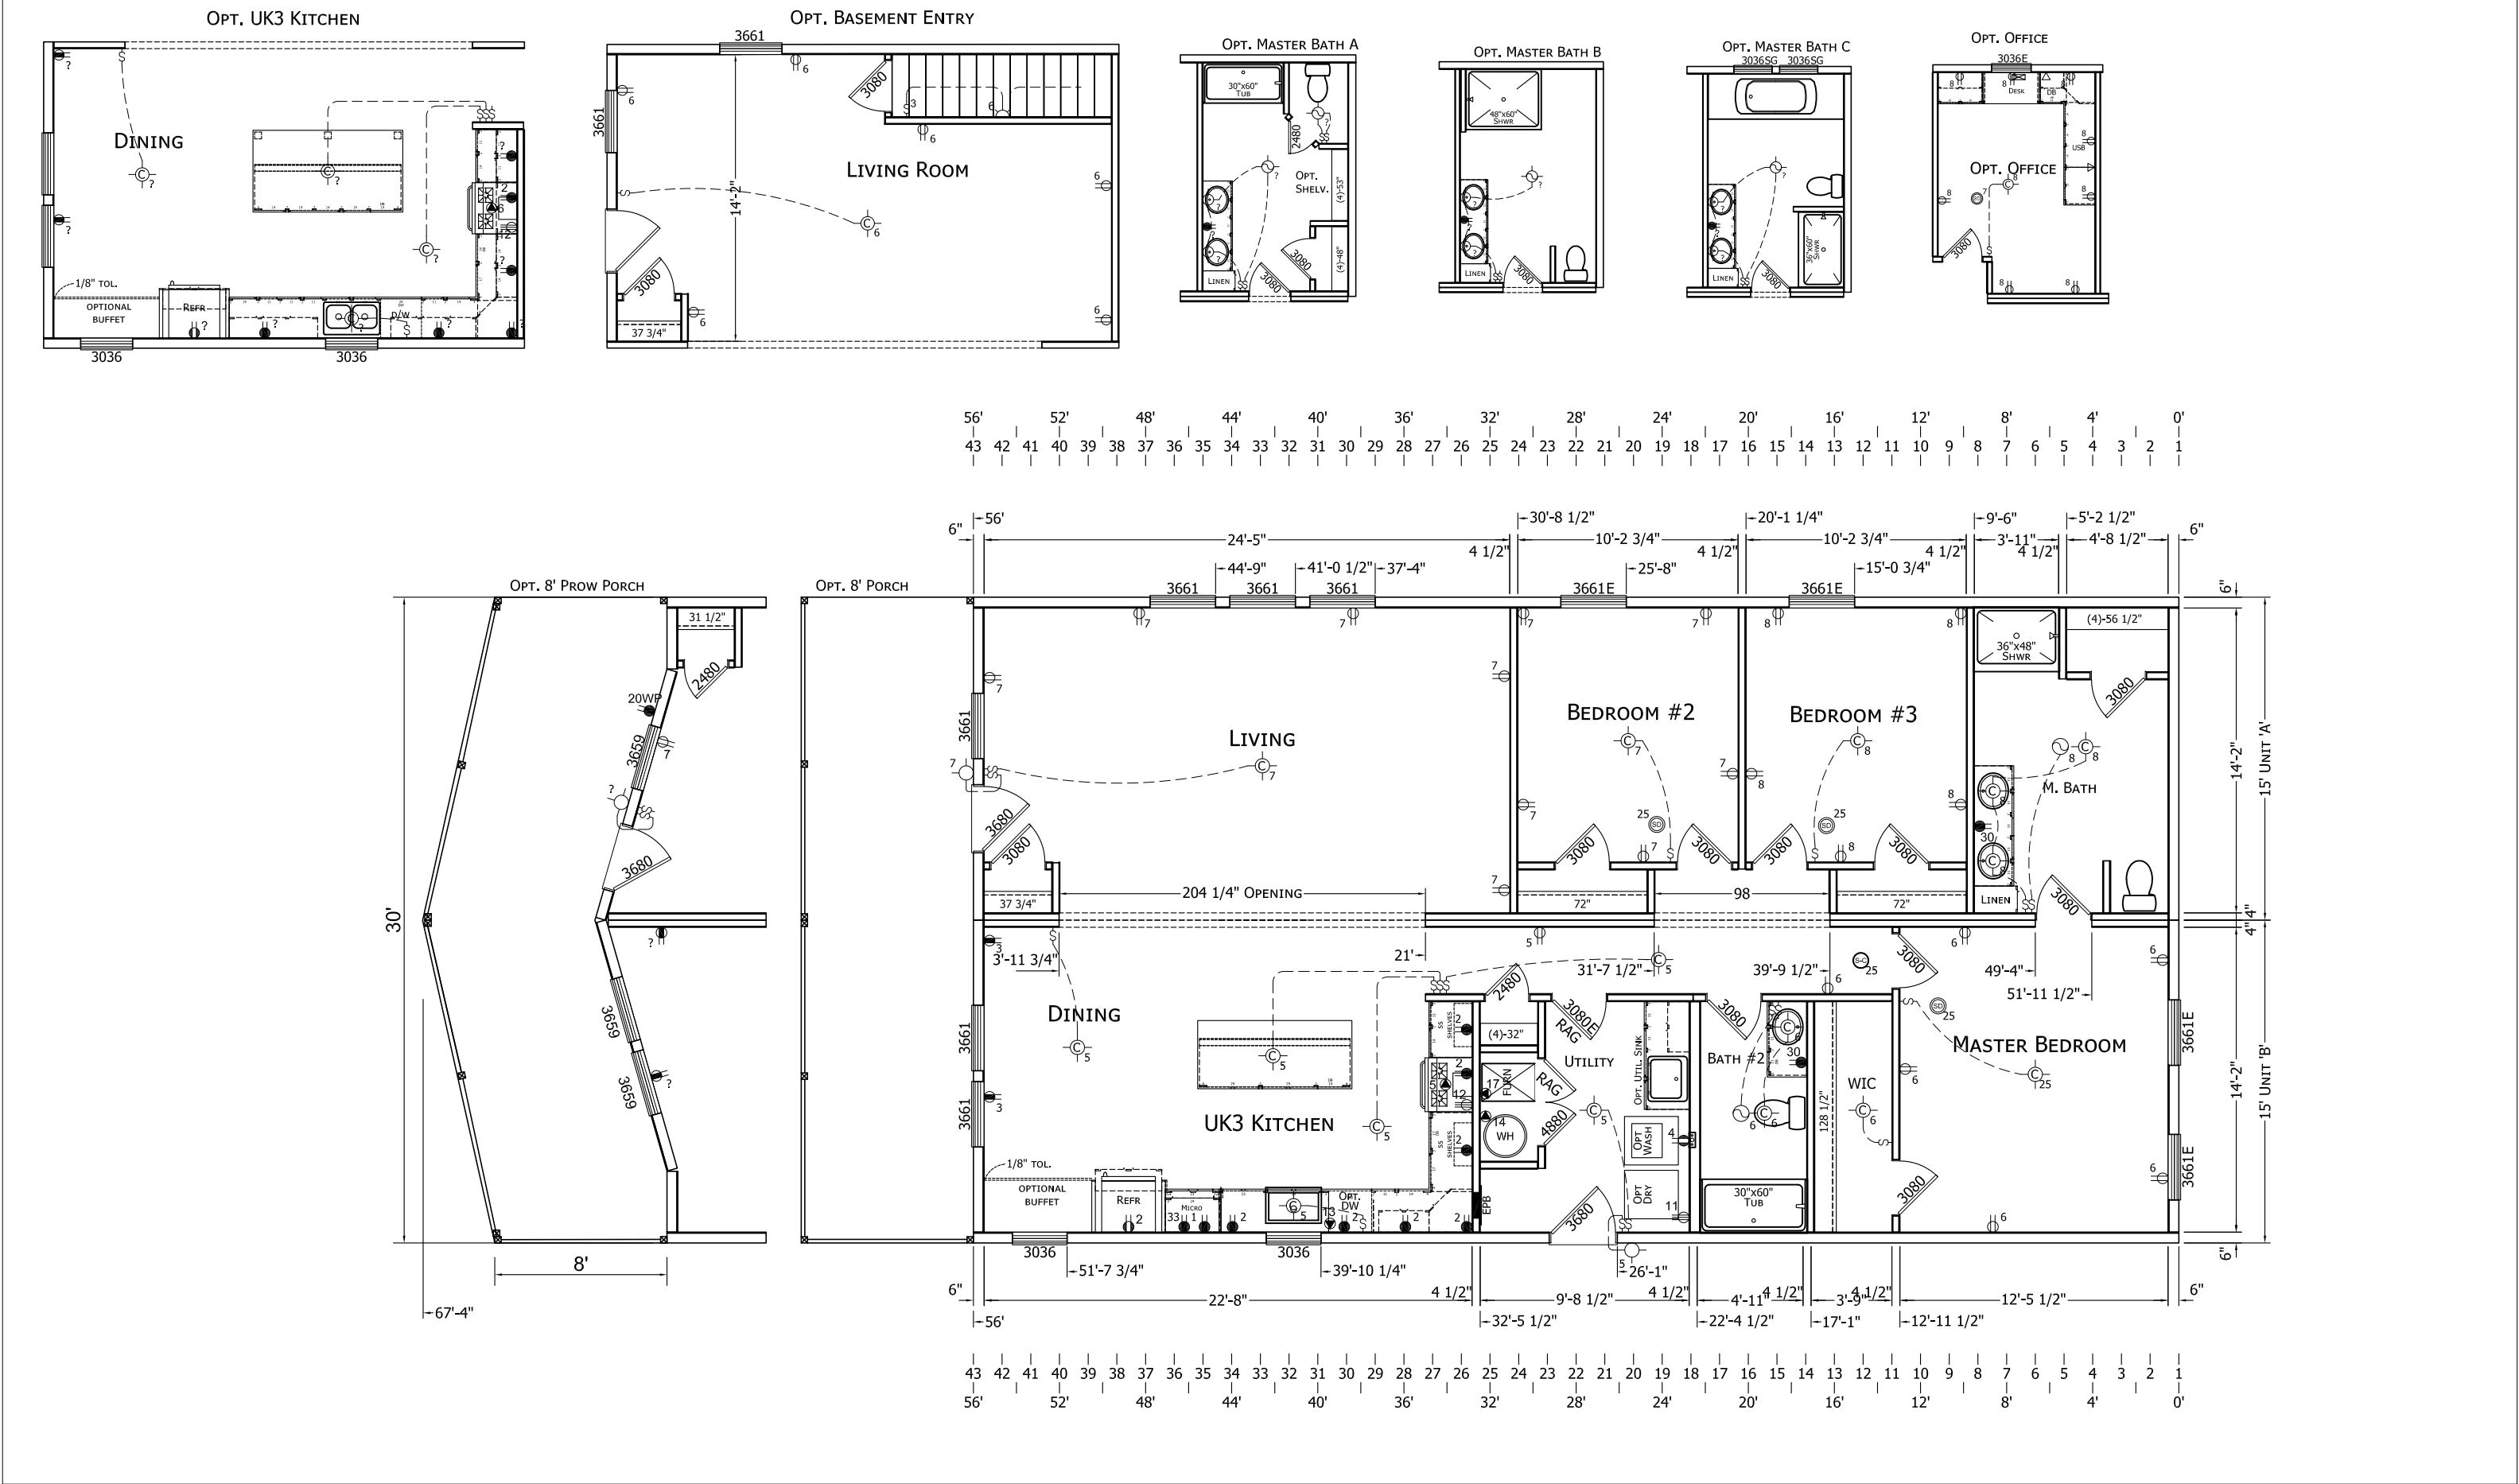

MODIFICATIONS

PROJECT:
005-CN204
29'-0" x 56'-0"
3 BD 2 BTH

DRAWN BY:
DATE: 06-02-26
SCALE: 5/32" = 1'-0"

TITLE:
FLOOR PLAN
ELECTRICAL PLAN

FILENAME: 05-CN204 STANDARDIZED 30' MOD

SHEET:
AP-101

PROPRIETARY AND CONFIDENTIAL
THESE DRAWINGS AND SPECIFICATIONS ARE ORIGINAL,
PROPRIETARY AND CONFIDENTIAL MATERIALS OF CHAMPION.
COPYRIGHT © 1976-2026 BY CHAMPION